


NOTE: OPEN TO DIFFERENT HEIGHT CONFIGURATIONS FOR AUDIENCE ON STEEL DECK IF THERE IS A MORE STANDARD SETUP
TOTAL HOUSE SEATS : 75




Line Set Schedule		
LS #	PL Distance	Line Set Schedule
35	26' - 4"	FULL STAGE BLACK AND SIDE TAB
34		Open 34
33	25' - 3/8"	Open 33
32		SIDE TAB 32
31		Open 31
30	23' - 4 3/8"	Open 30
29		Open 29
28	23' - 3 7/8"	Open 28
27	21' - 4 3/8"	Open 27
26	20' - 4 3/8"	4 PRACTICAL LIGHTS 26
25	19' - 4 3/8"	Open 25
24	18' - 6 1/8"	Open 24
23	17' - 8 1/8"	Open 23
22	16' - 10 1/8"	Open 22
21	16' - 10 1/8"	Open 21
20	15' - 2 1/8"	Open 20
19	14' - 4 1/8"	Open 19
18	13' - 6 1/8"	3 PRACTICAL LIGHTS 18
17	12' - 7 7/8"	Open 17
16	11' - 4 5/8"	Open 16
15	11' - 0 1/8"	Open 15
14	10' - 2 1/8"	Open 14
13	9' - 4 1/8"	Open 13
12	8' - 7 1/2"	Open 12
11	8' - 2 1/2"	Open 11
10	7' - 1 1/2"	Open 10
9	6' - 4"	Open 9
8	5' - 7 3/8"	Open 8
7	4' - 10 1/2"	Open 7
6	4' - 1 1/2"	MASKING 6
5	3' - 0"	3 PRACTICAL LIGHTS 5
4	2' - 1 1/2"	Open 4
3	1' - 3 1/2"	Open 3
2	0' - 11"	Open 2
1	0' - 6 1/2"	Main 1

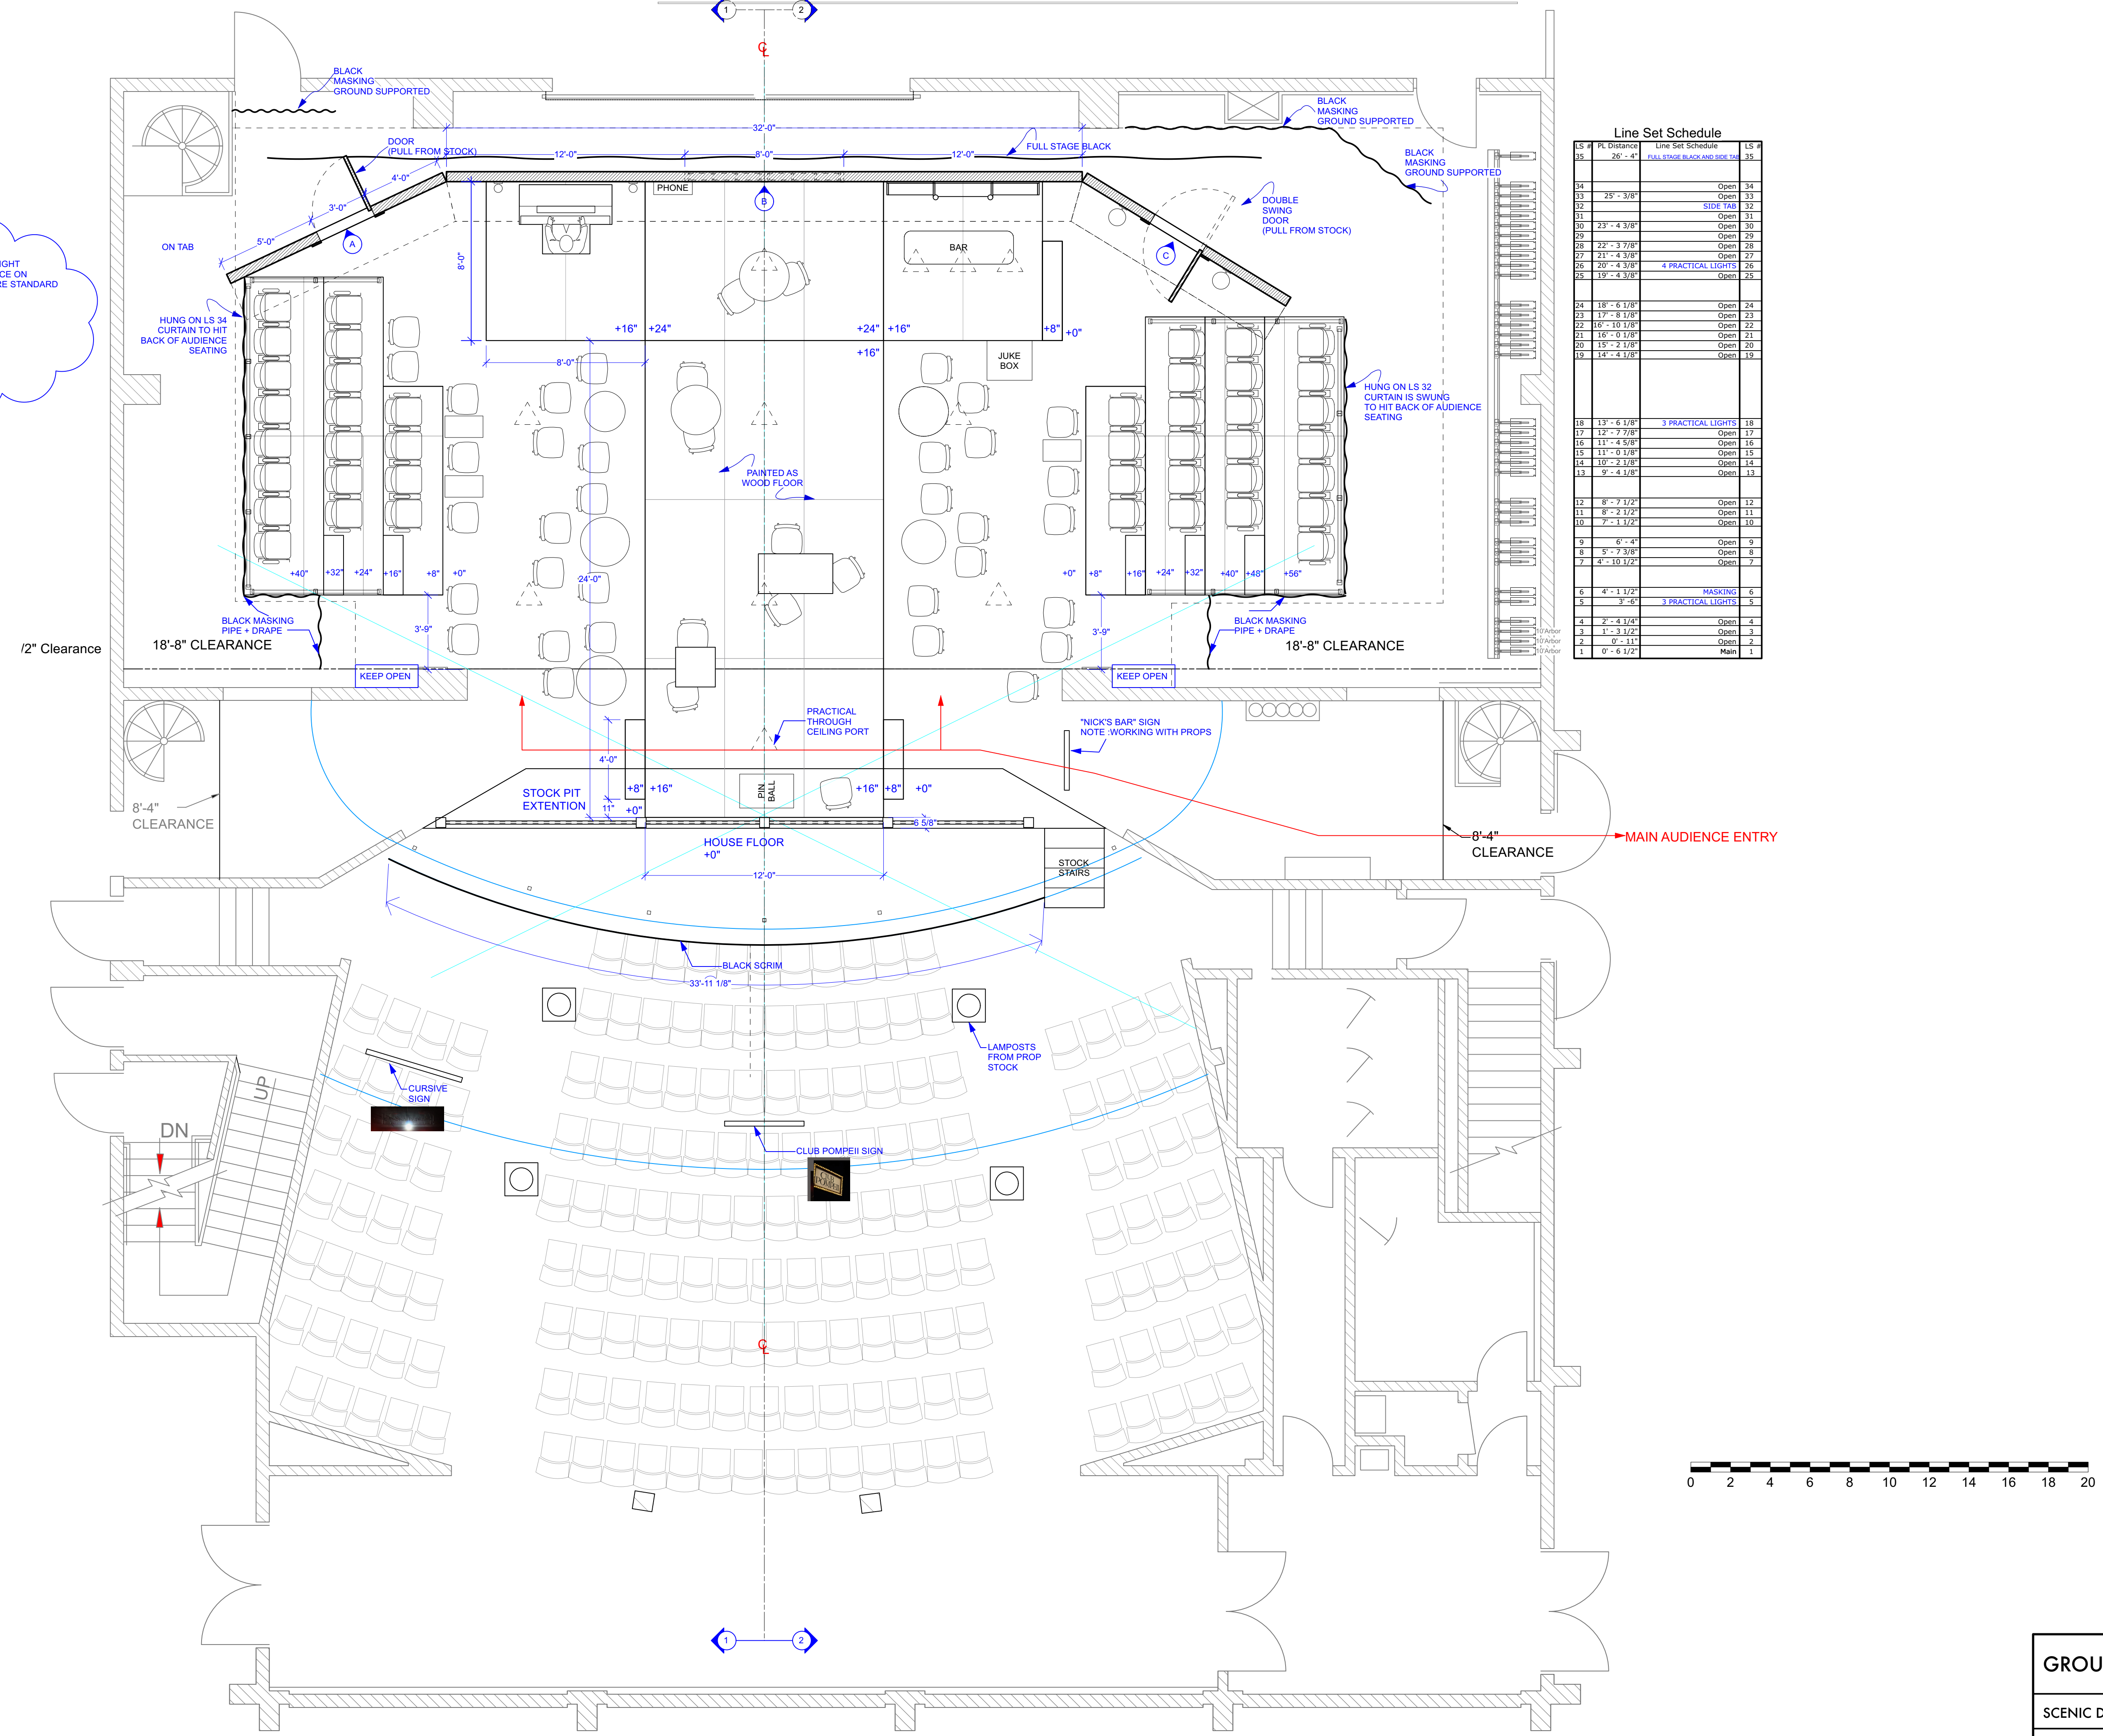


GROUND PLAN
SCALE: 1/4" = 1'-0"

GROUNDPLAN	SCALE: 1/4" = 1'-0"
SCENIC DESIGN: MARI YOSHIDA	NO. 1
DIRECTOR: JENNIFER CHANG	OF 6
TIME OF YOUR LIFE	DATE: 8/26/23
LITTLE THEATER UCLA	

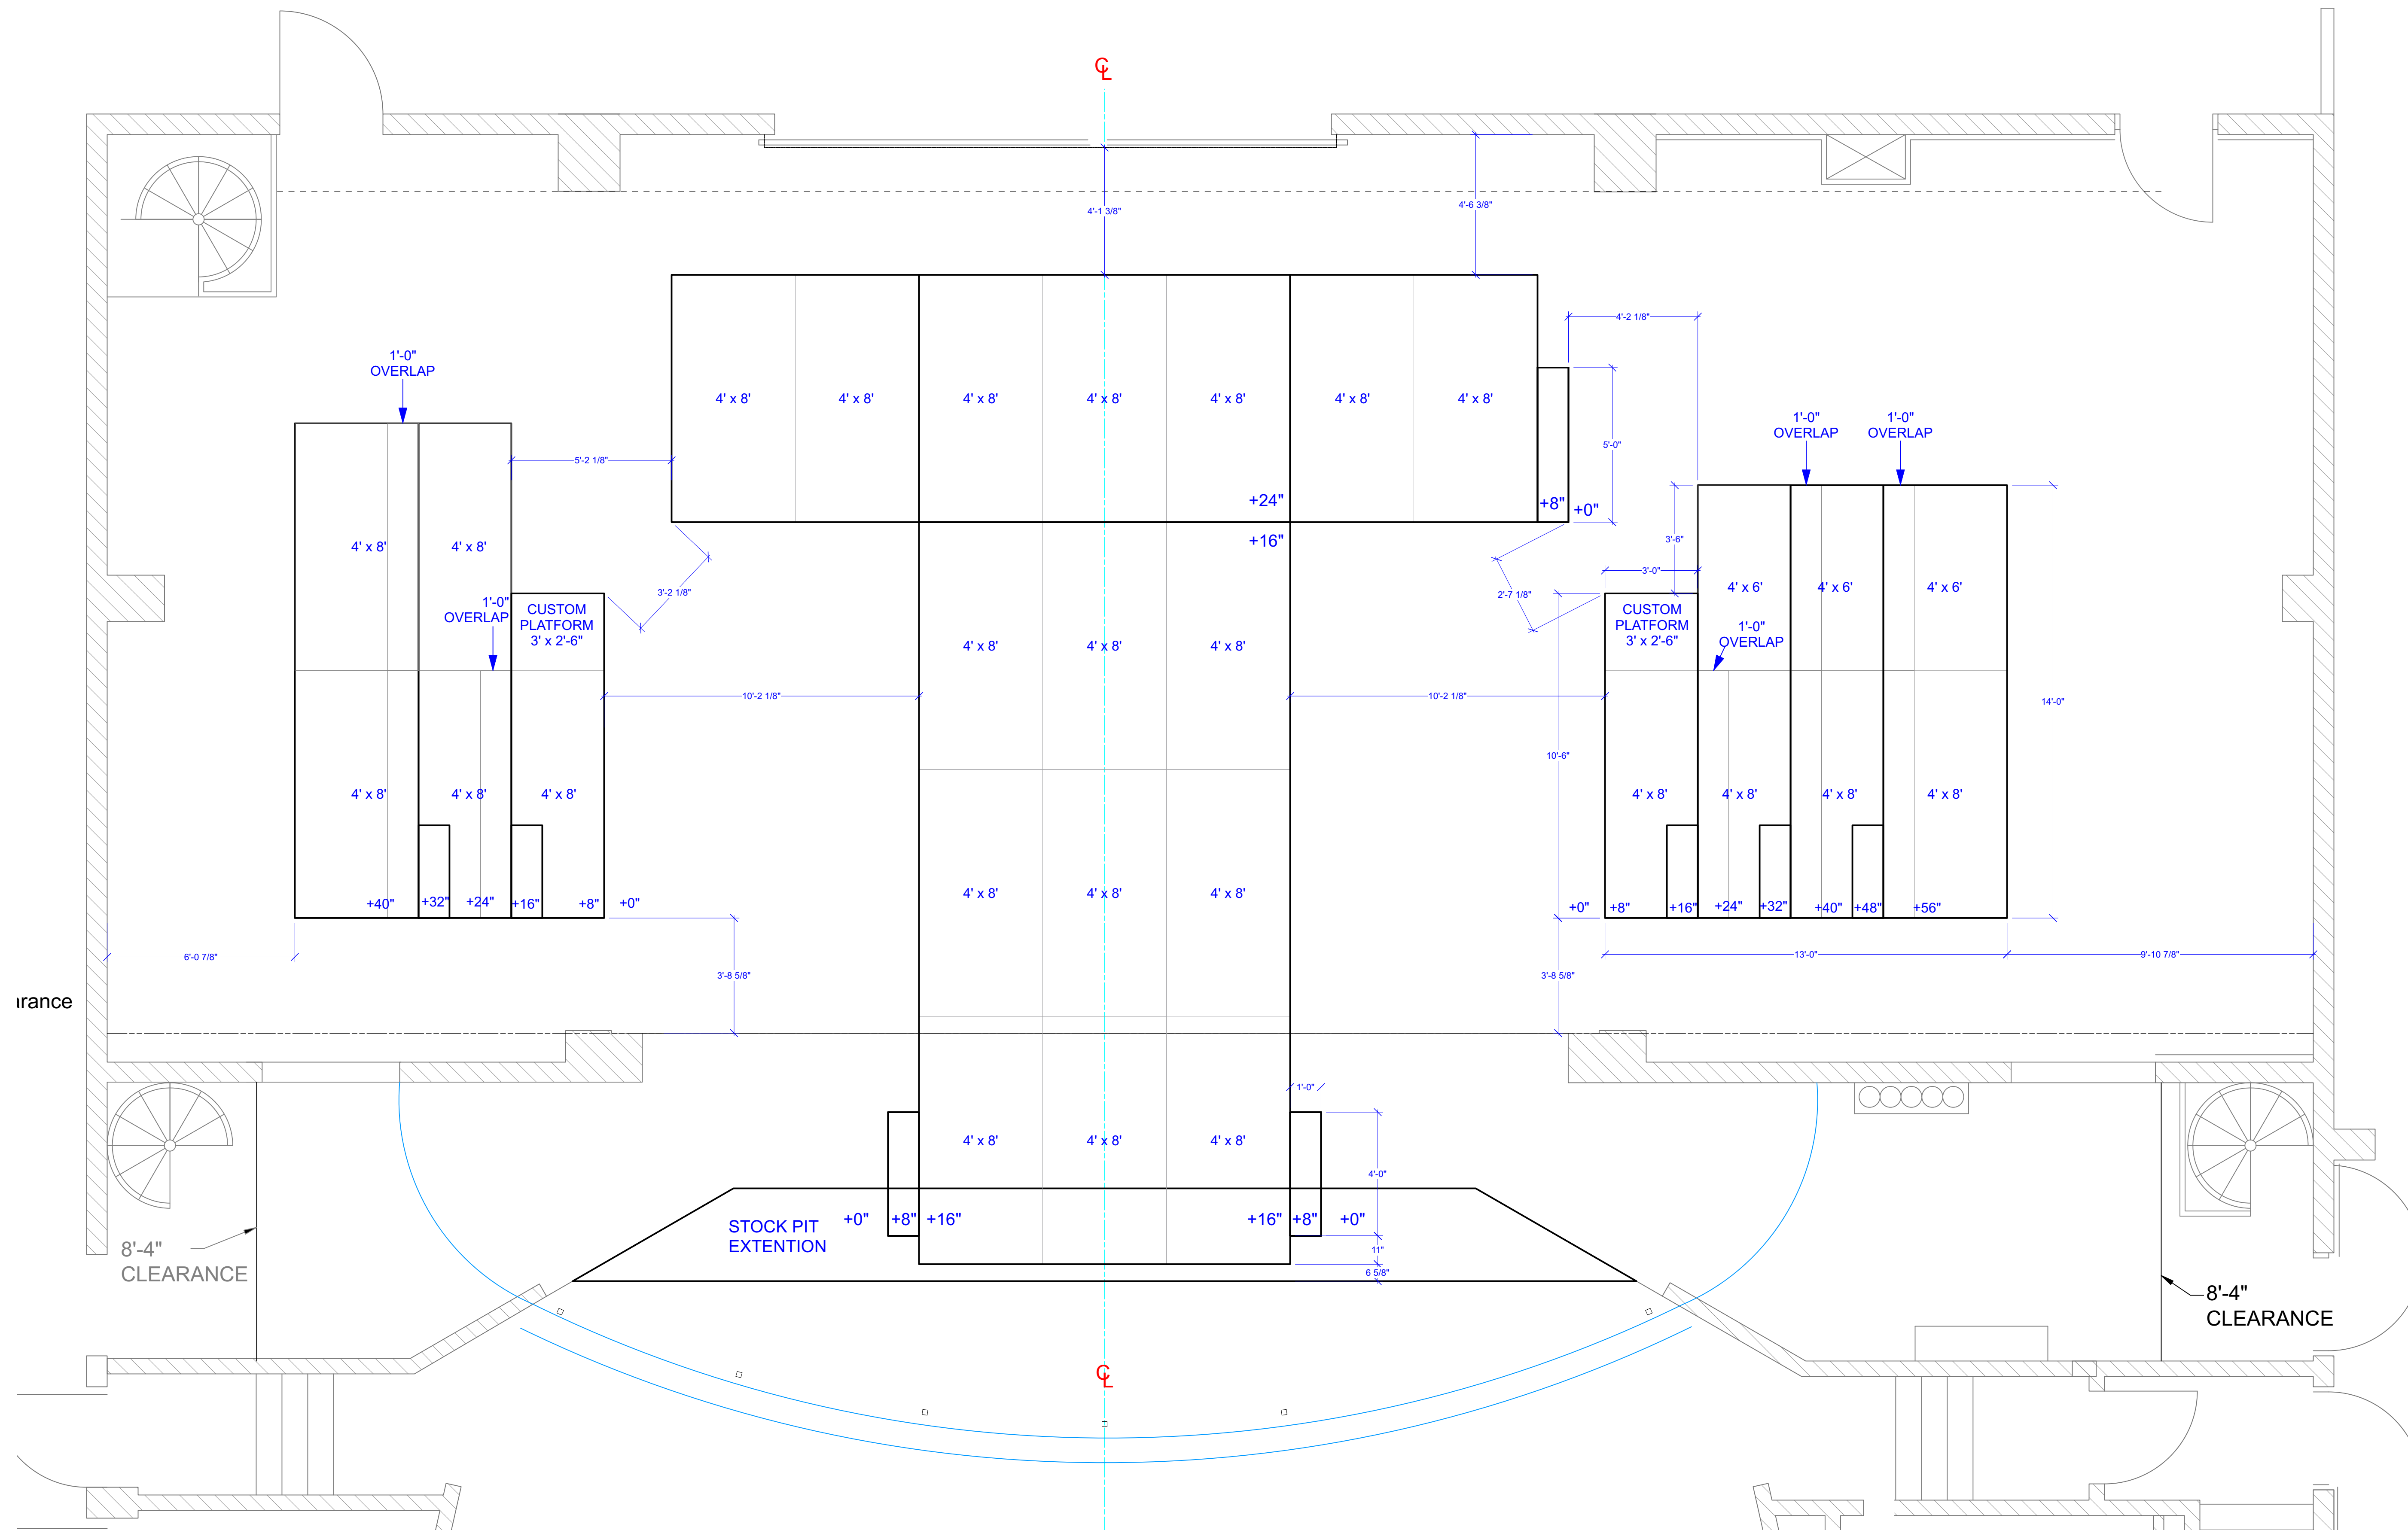


DECK PLAN
SCALE : 3/8" = 1'-0"

DECK PLAN	SCALE: 3/8" = 1'-0"
SCENIC DESIGN: MARI YOSHIDA	NO.
DIRECTOR: JENNIFER CHANG	3
TIME OF YOUR LIFE	OF 6
LITTLE THEATER UCLA	DATE: 8/26/23

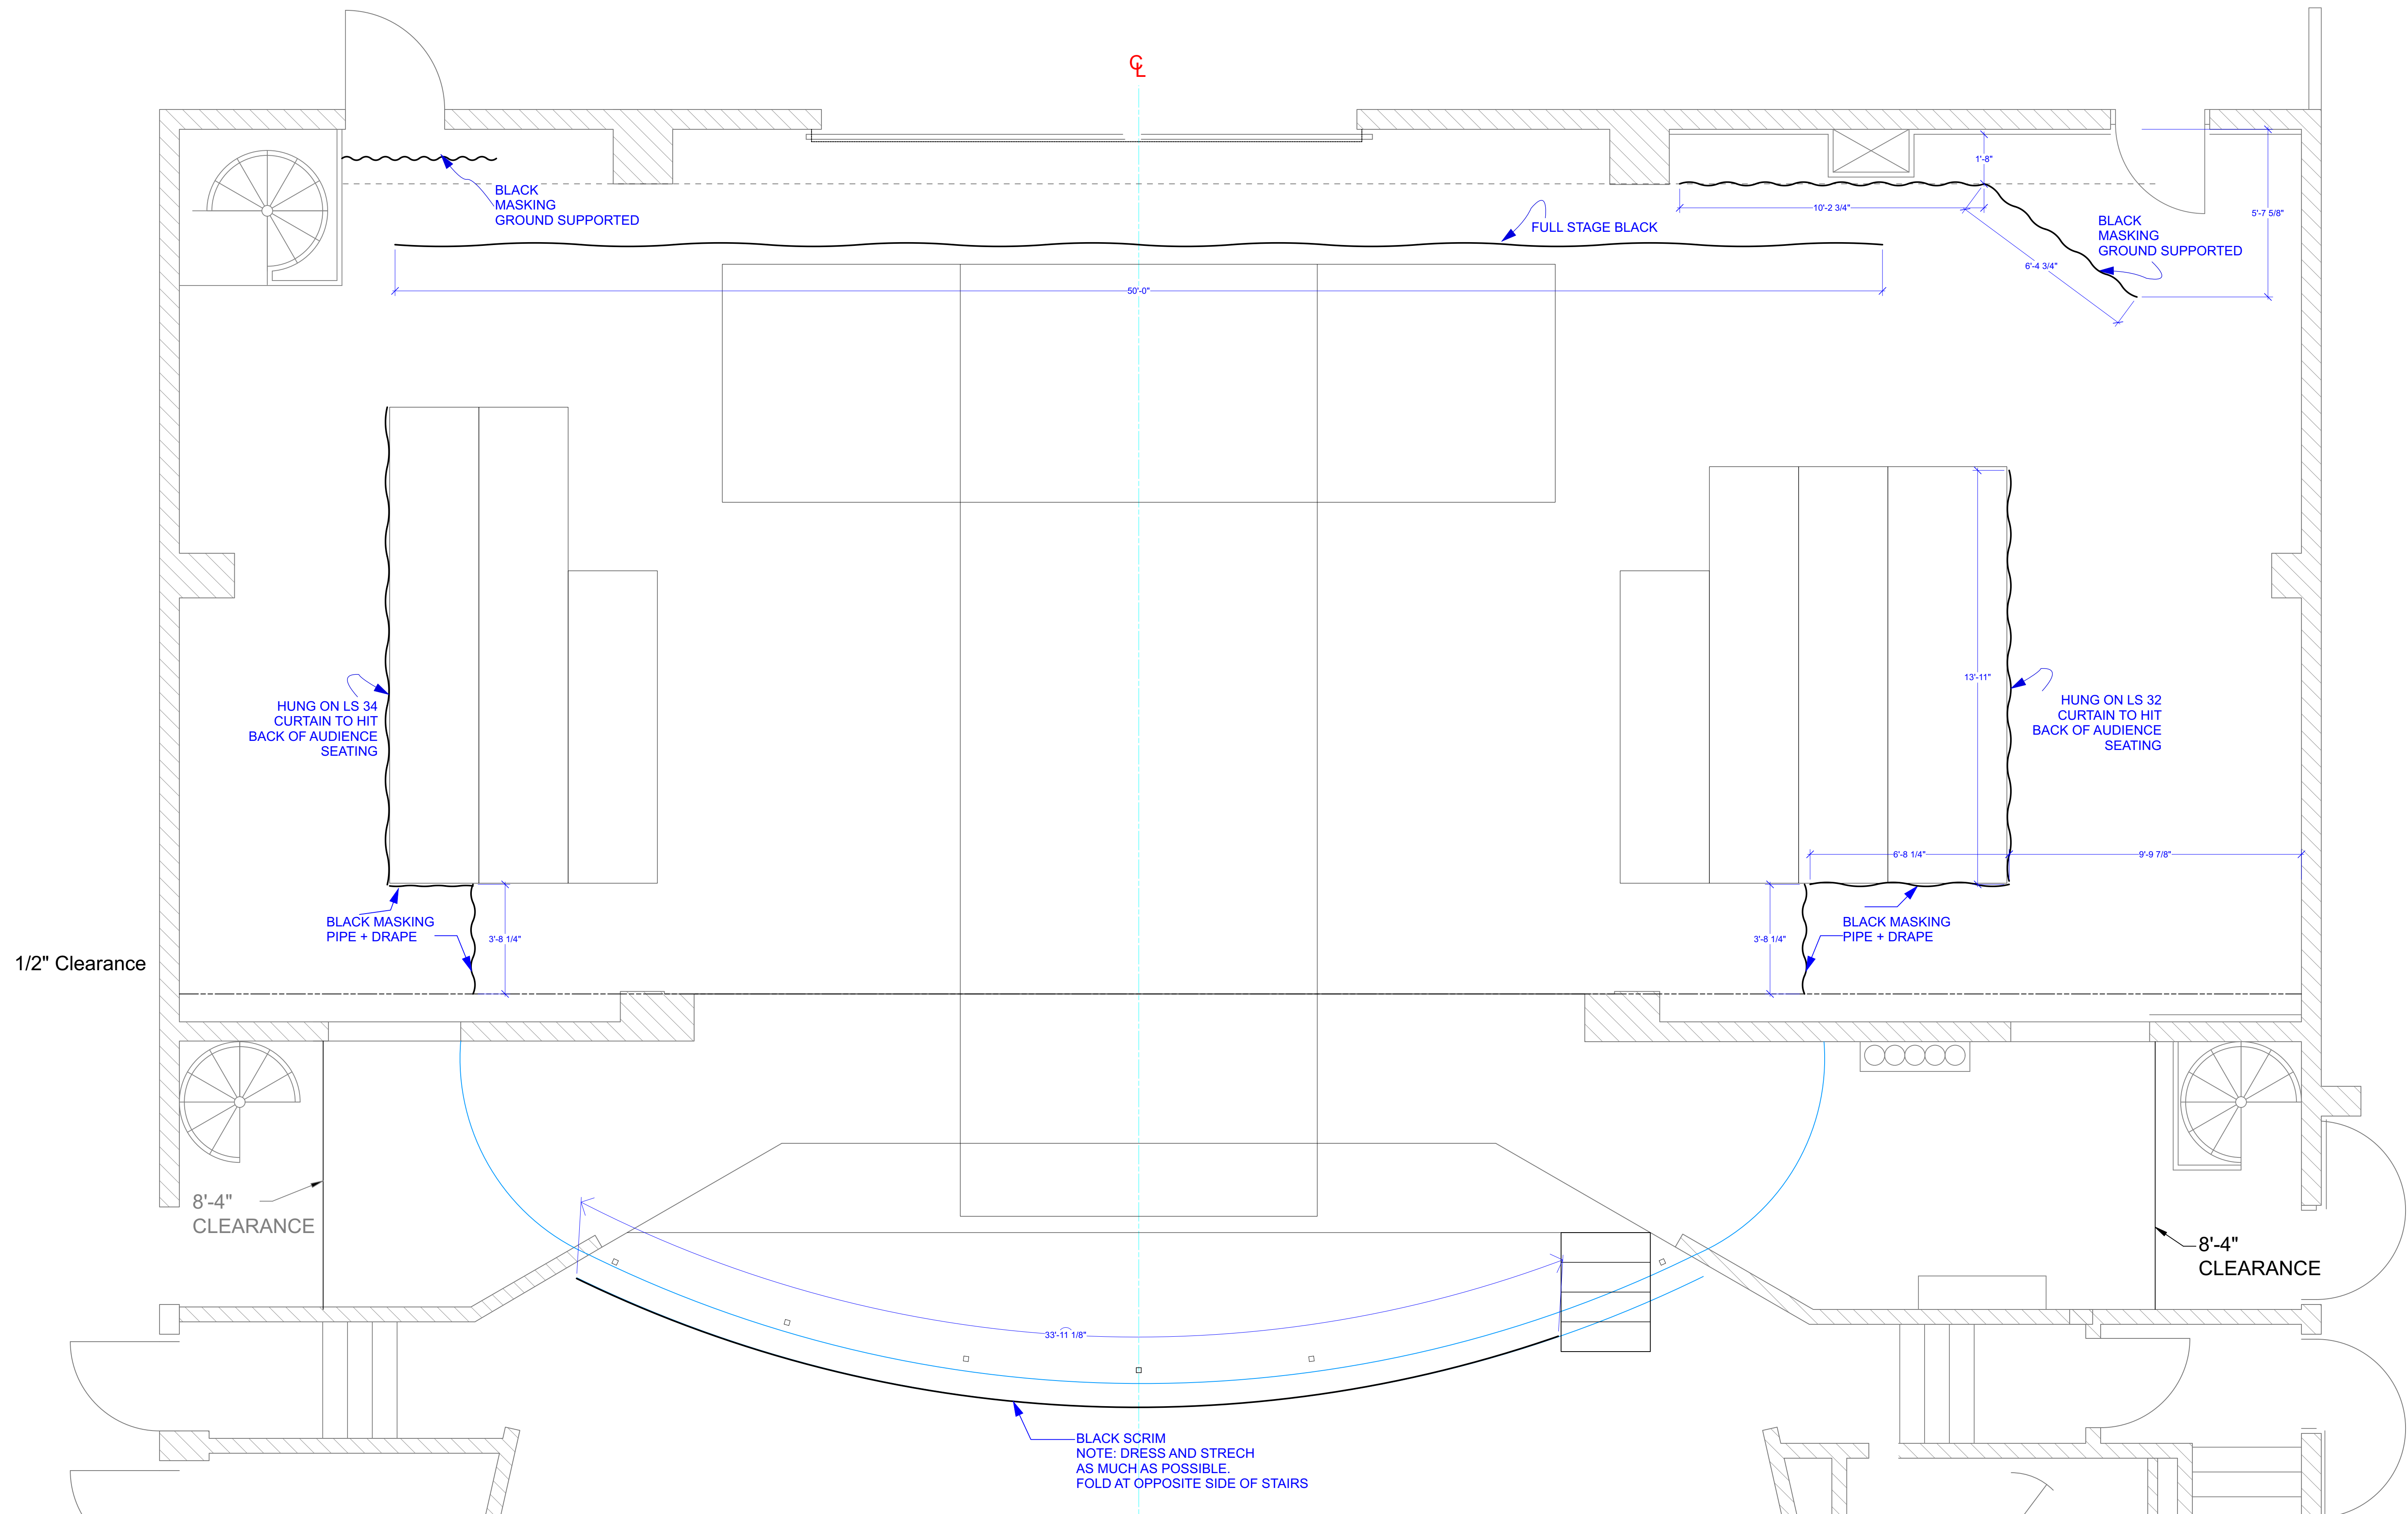


MASKING PLAN
 SCALE : 3/8" = 1'-0"


MASKING PLAN	SCALE: 3/8" = 1'-0"
SCENIC DESIGN: MARI YOSHIDA	NO.
DIRECTOR: JENNIFER CHANG	4
TIME OF YOUR LIFE	OF 6
LITTLE THEATER UCLA	DATE: 8/26/23

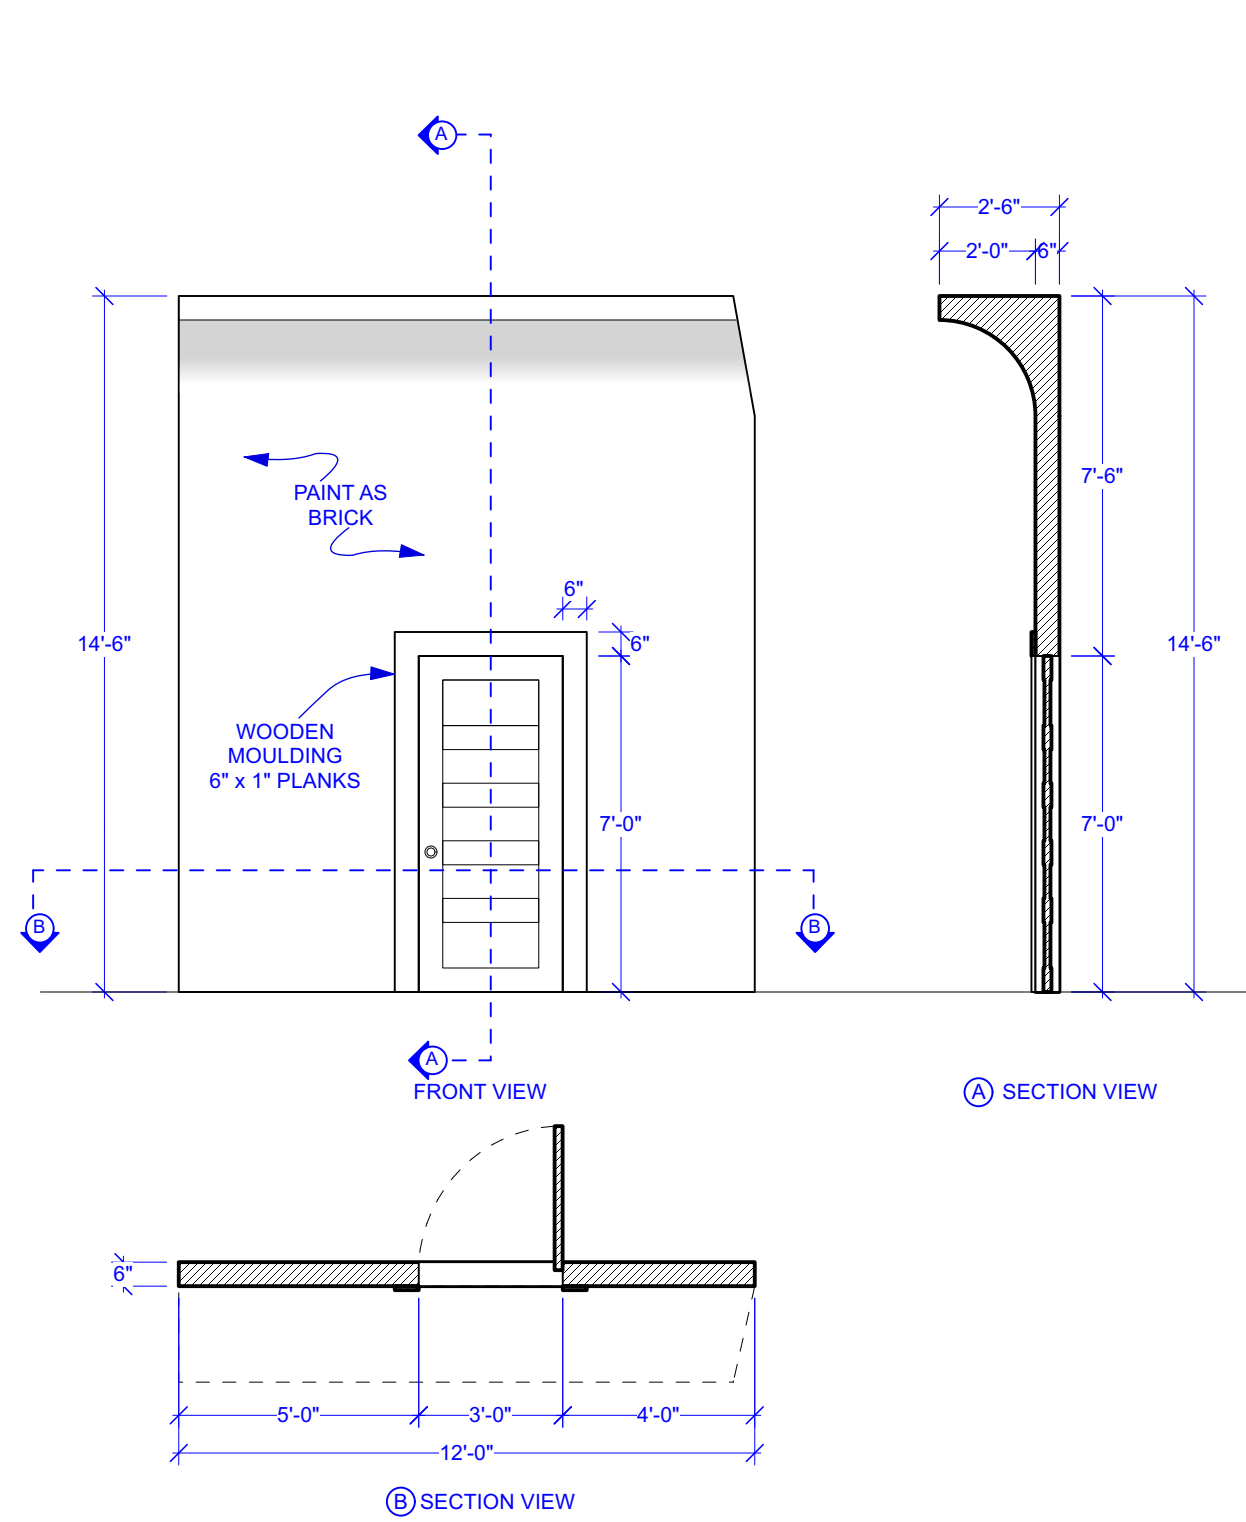

WALL A
SCALE : 1/4" = 1'-0"


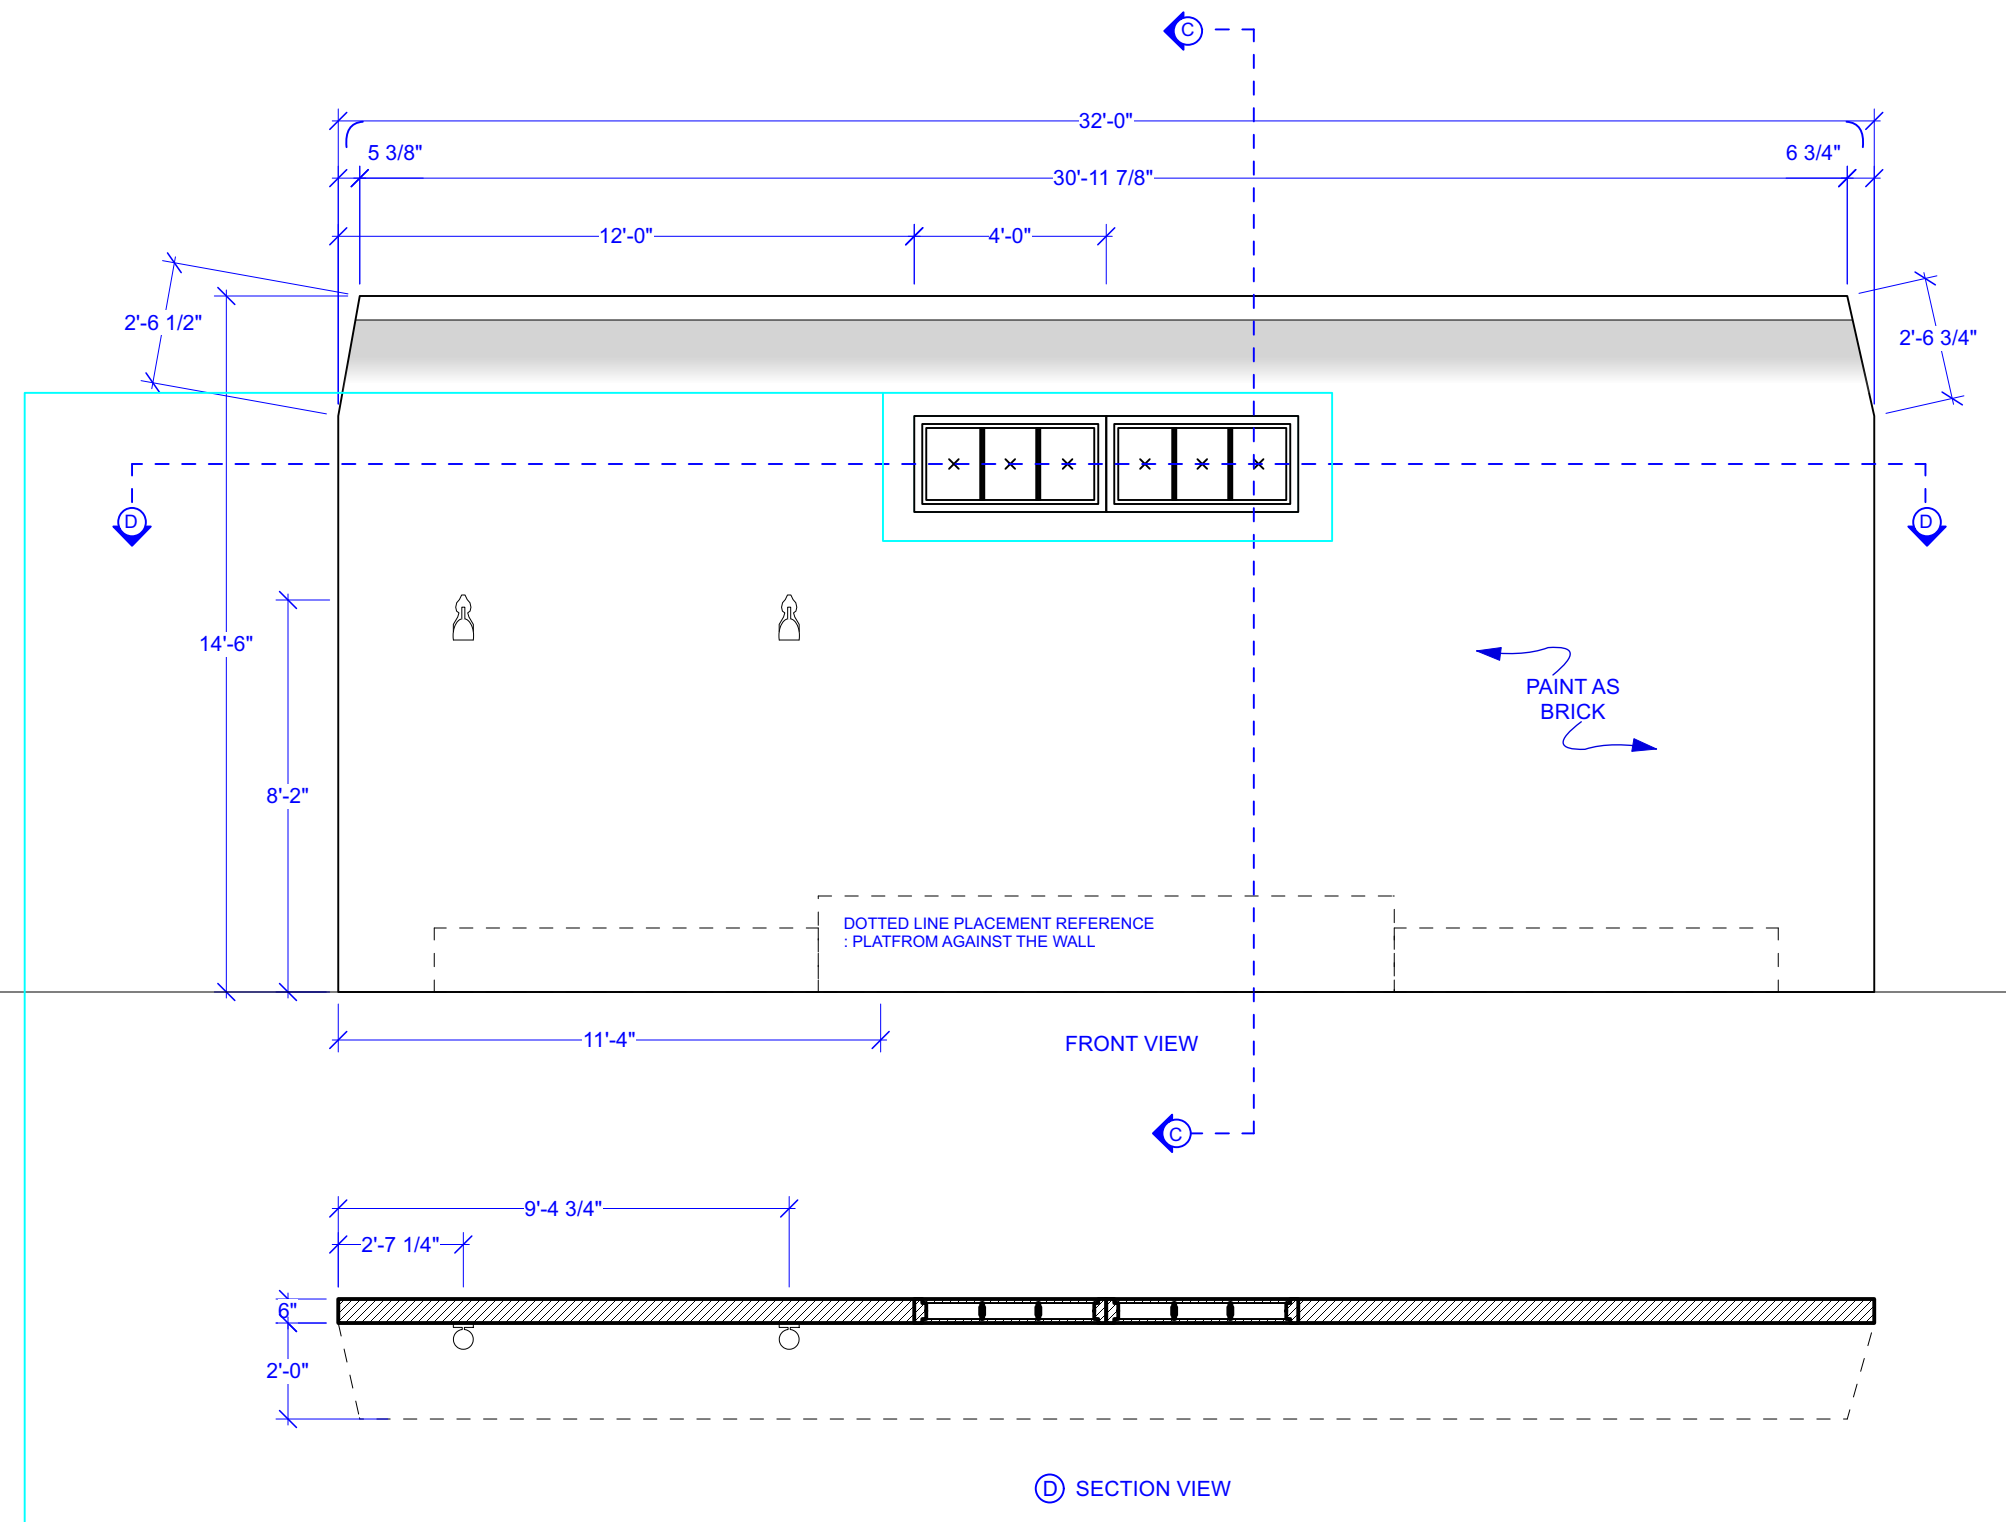


WALL B
SCALE : 1/4" = 1'-0"

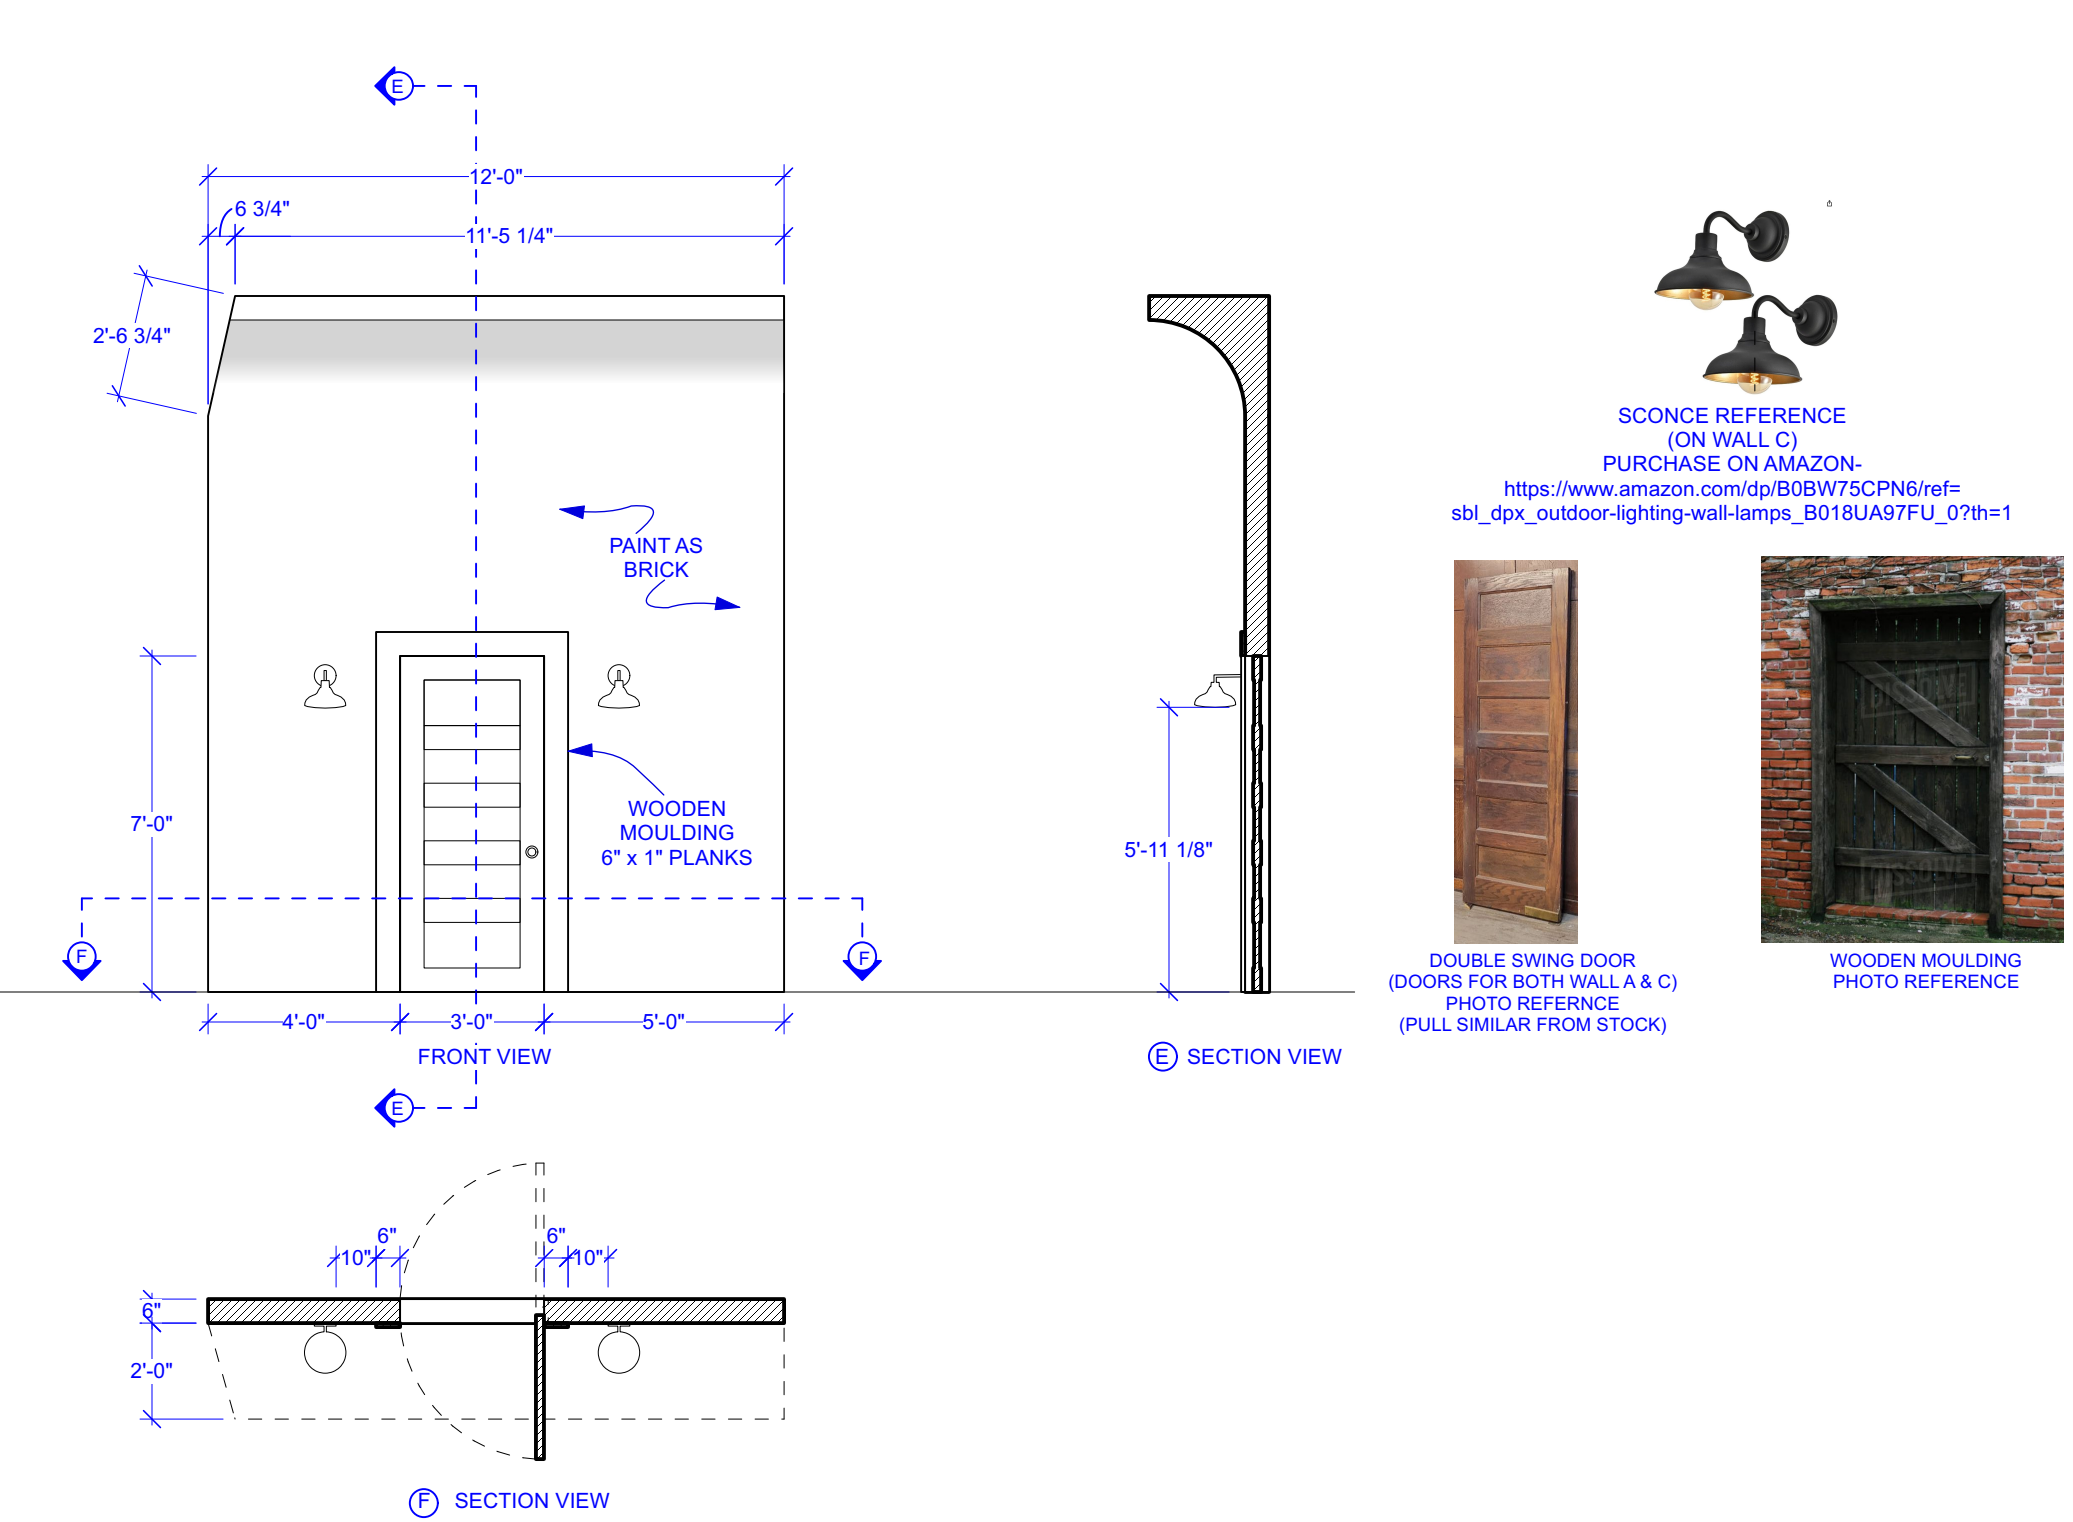

WALL C
SCALE : 1/4" = 1'-0"

NOTE:
ON WALLS A - C WILL HAVE OBJECTS ATTACHED SUCH AS FRAMES, TRINKETS SO WILL NEED SOME BACK SUPPORT WHEN ATTACHING THESE ITEMS. EACH INDIVIDUAL ITEM SHOULD NOT BE TOO HEAVY BUT AM PLANNING TO HAVE A HIGH DENSITY OF ITEMS HANGING. PICTURE BELOW FOR REFERENCE ON DENSITY OF ITEMS.

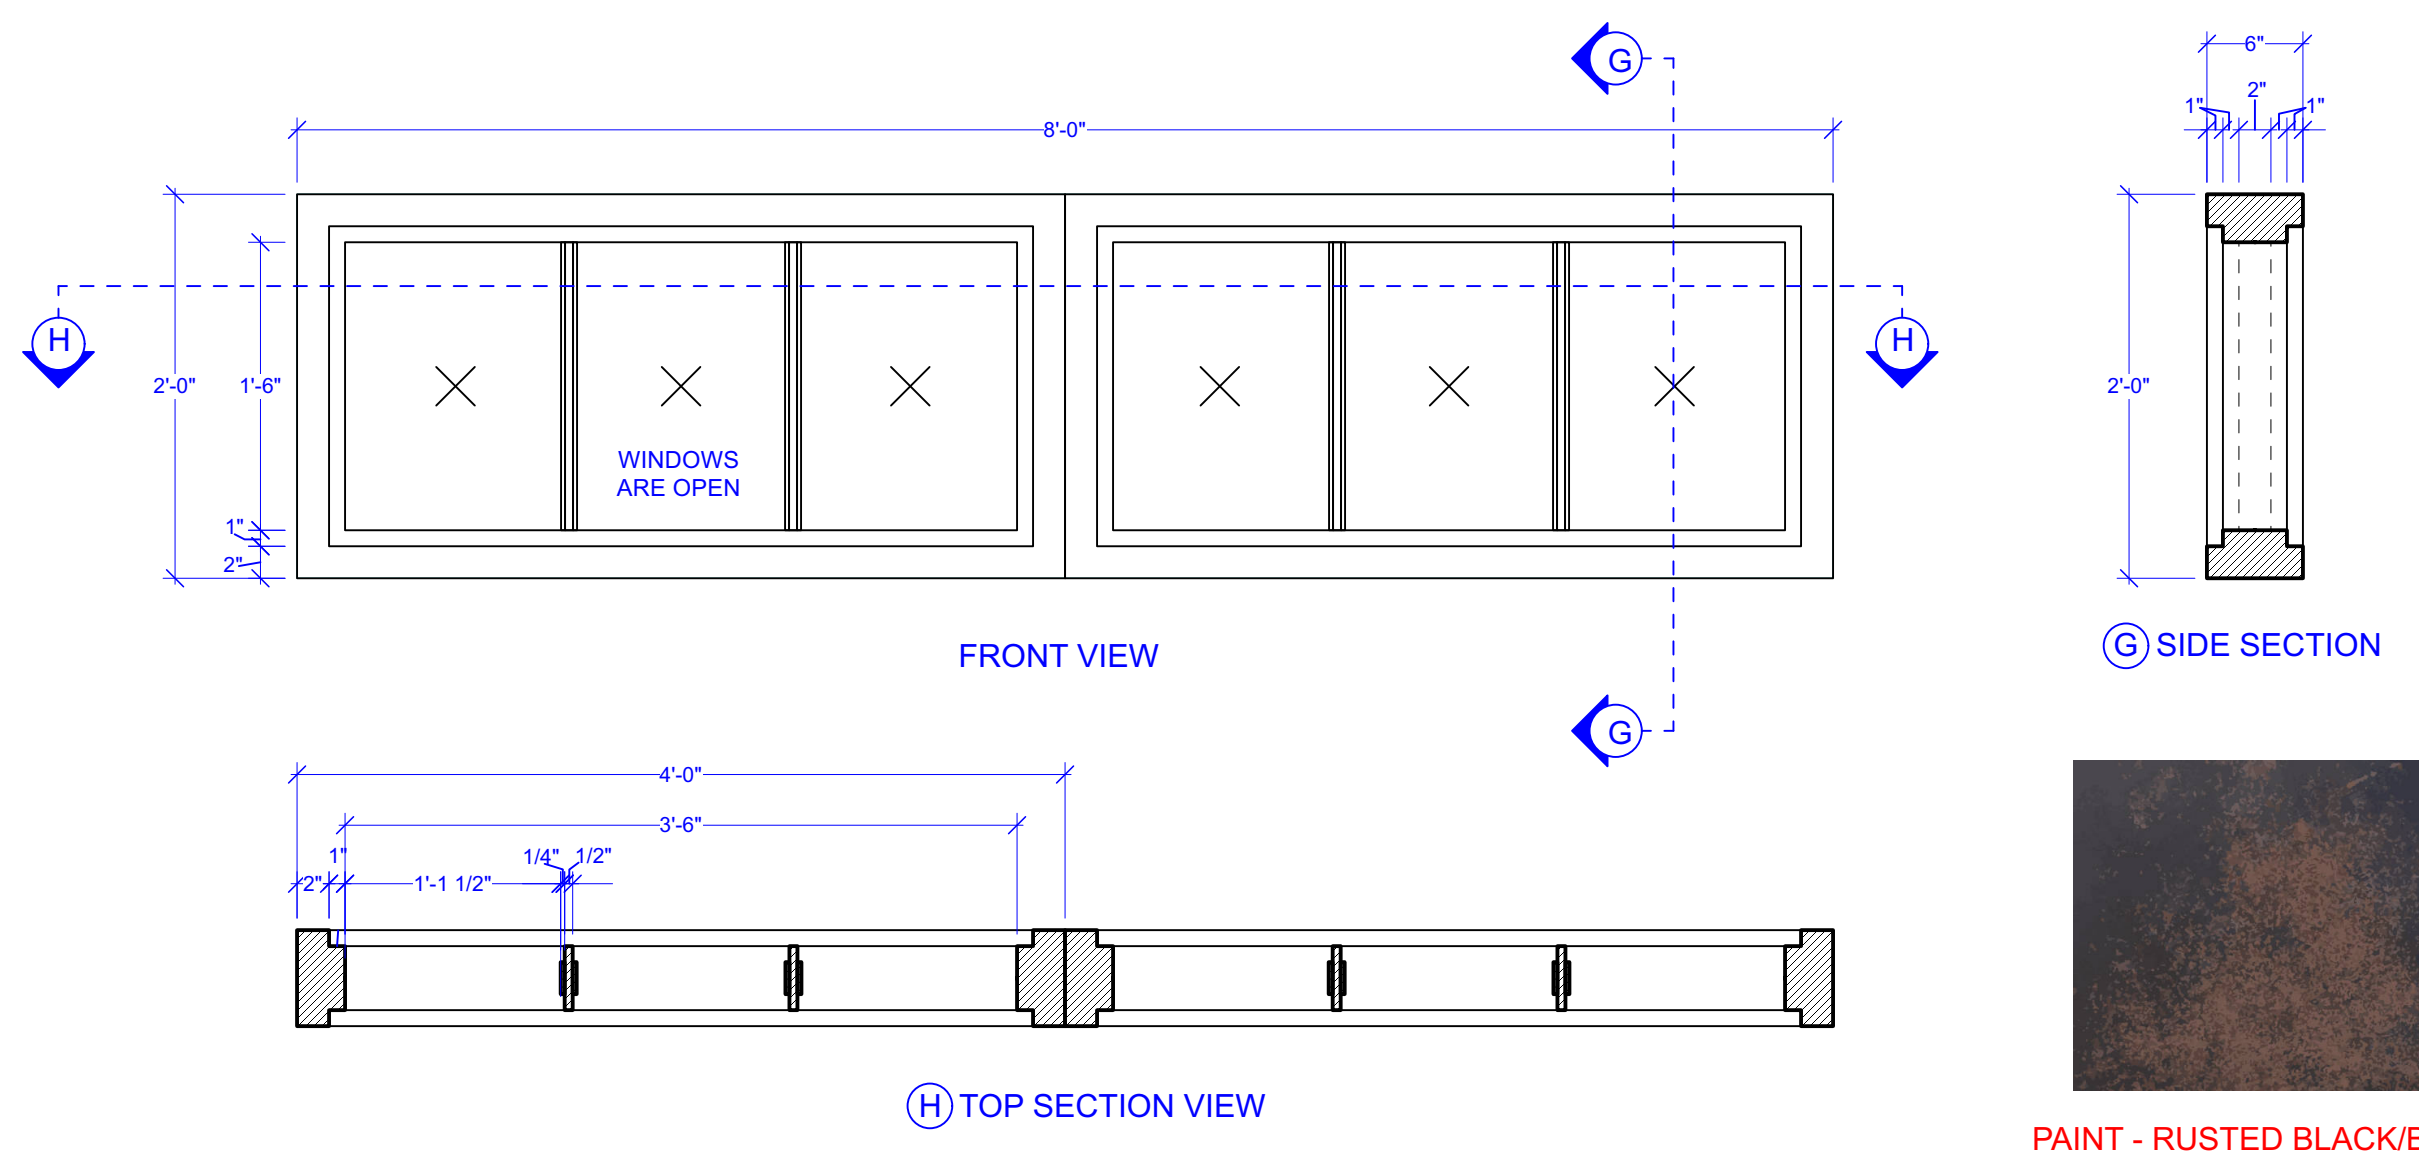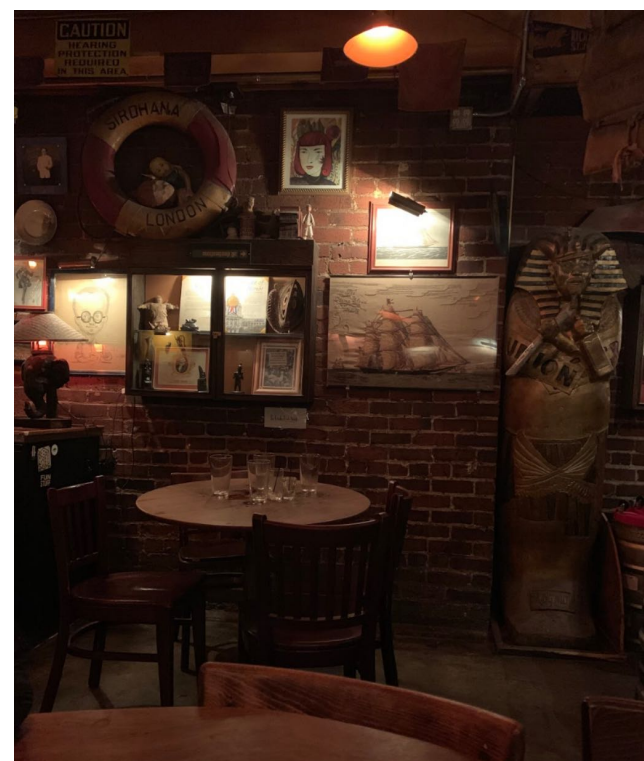



WINDOW DETAIL ON WALL B
SCALE : 1" = 1'-0"




NOTE : SIGNAGE FROM SWEET CHARITY HUNG IN AUDIENCE LOCATION DRAWN IN GP AND SECTION

SIGNAGE IN HOUSE
SCALE : N/A

ELEVATION 1	SCALE: AS NOTED
SCENIC DESIGN: MARI YOSHIDA	NO.
DIRECTOR: JENNIFER CHANG	5
TIME OF YOUR LIFE	OF 6
LITTLE THEATER UCLA	DATE: 8/26/23

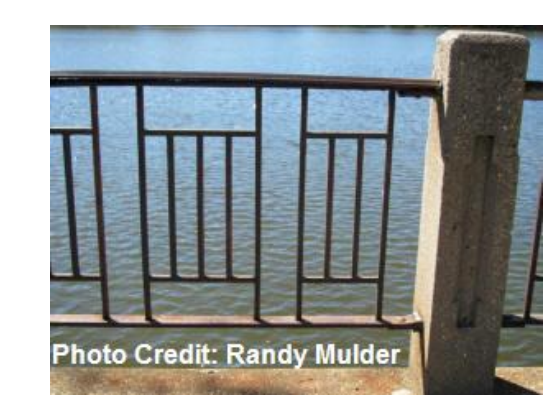
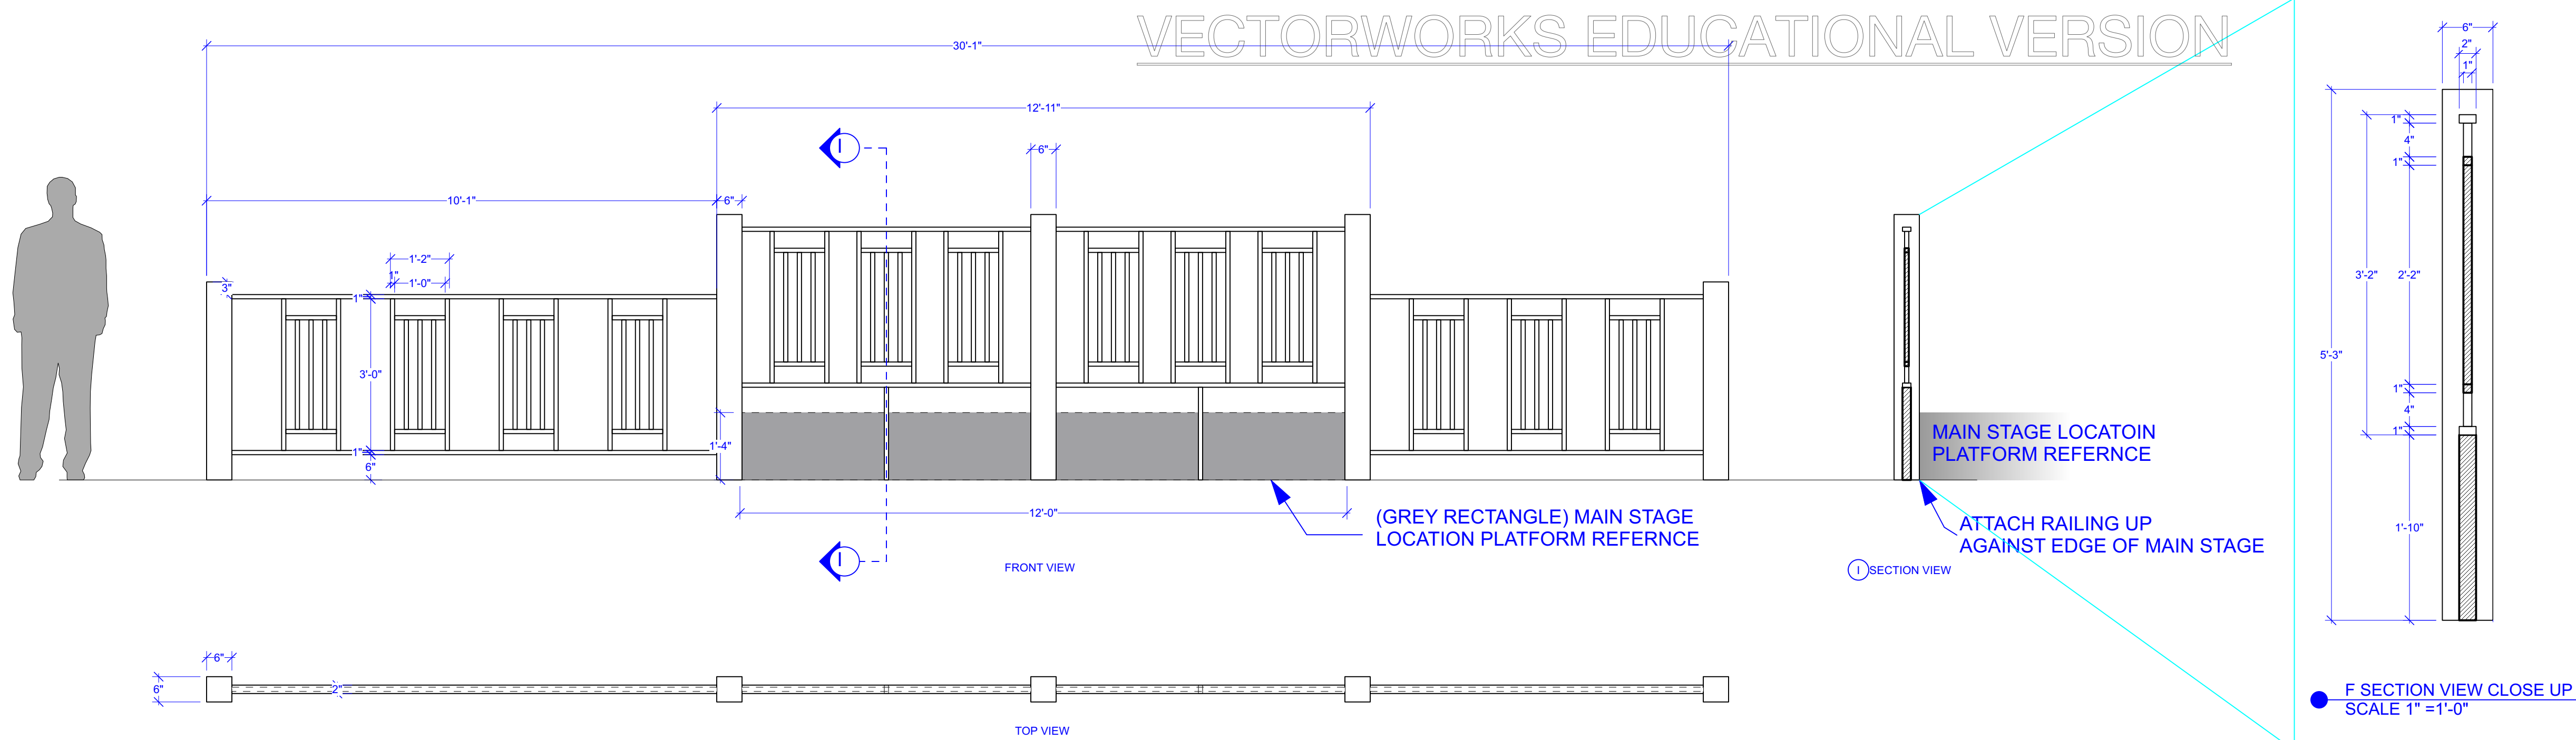


RAILING PHOTO REFERENCE

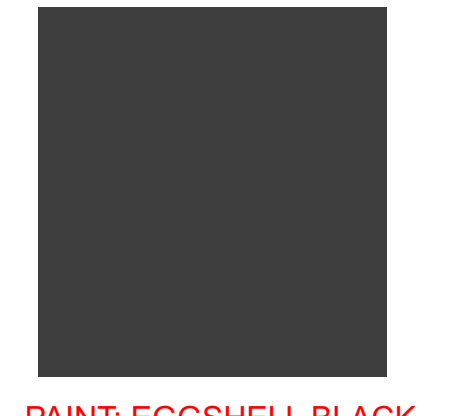

PAINT: EGGSHELL BLACK

RAILING ON PIT EXTENTION
SCALE : 1/2" = 1'-0"

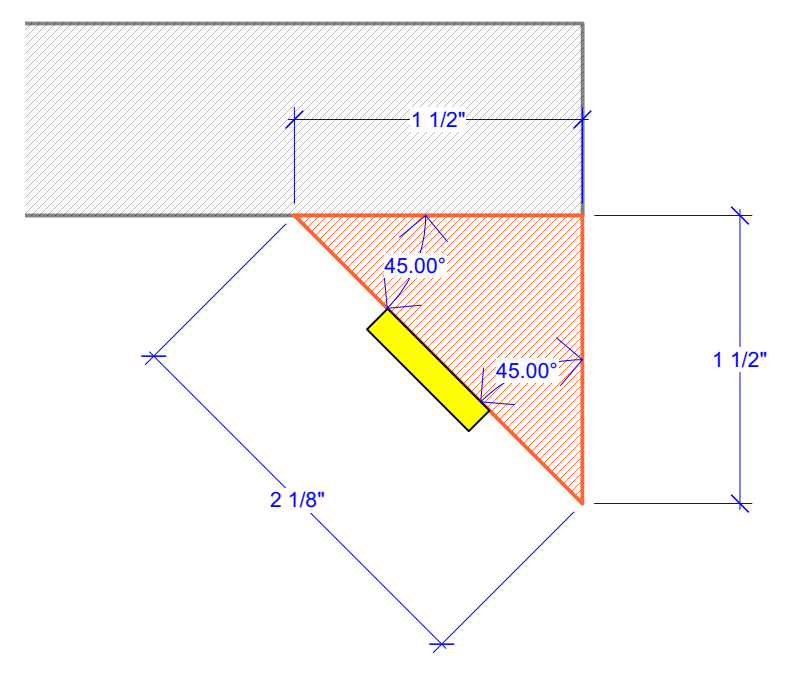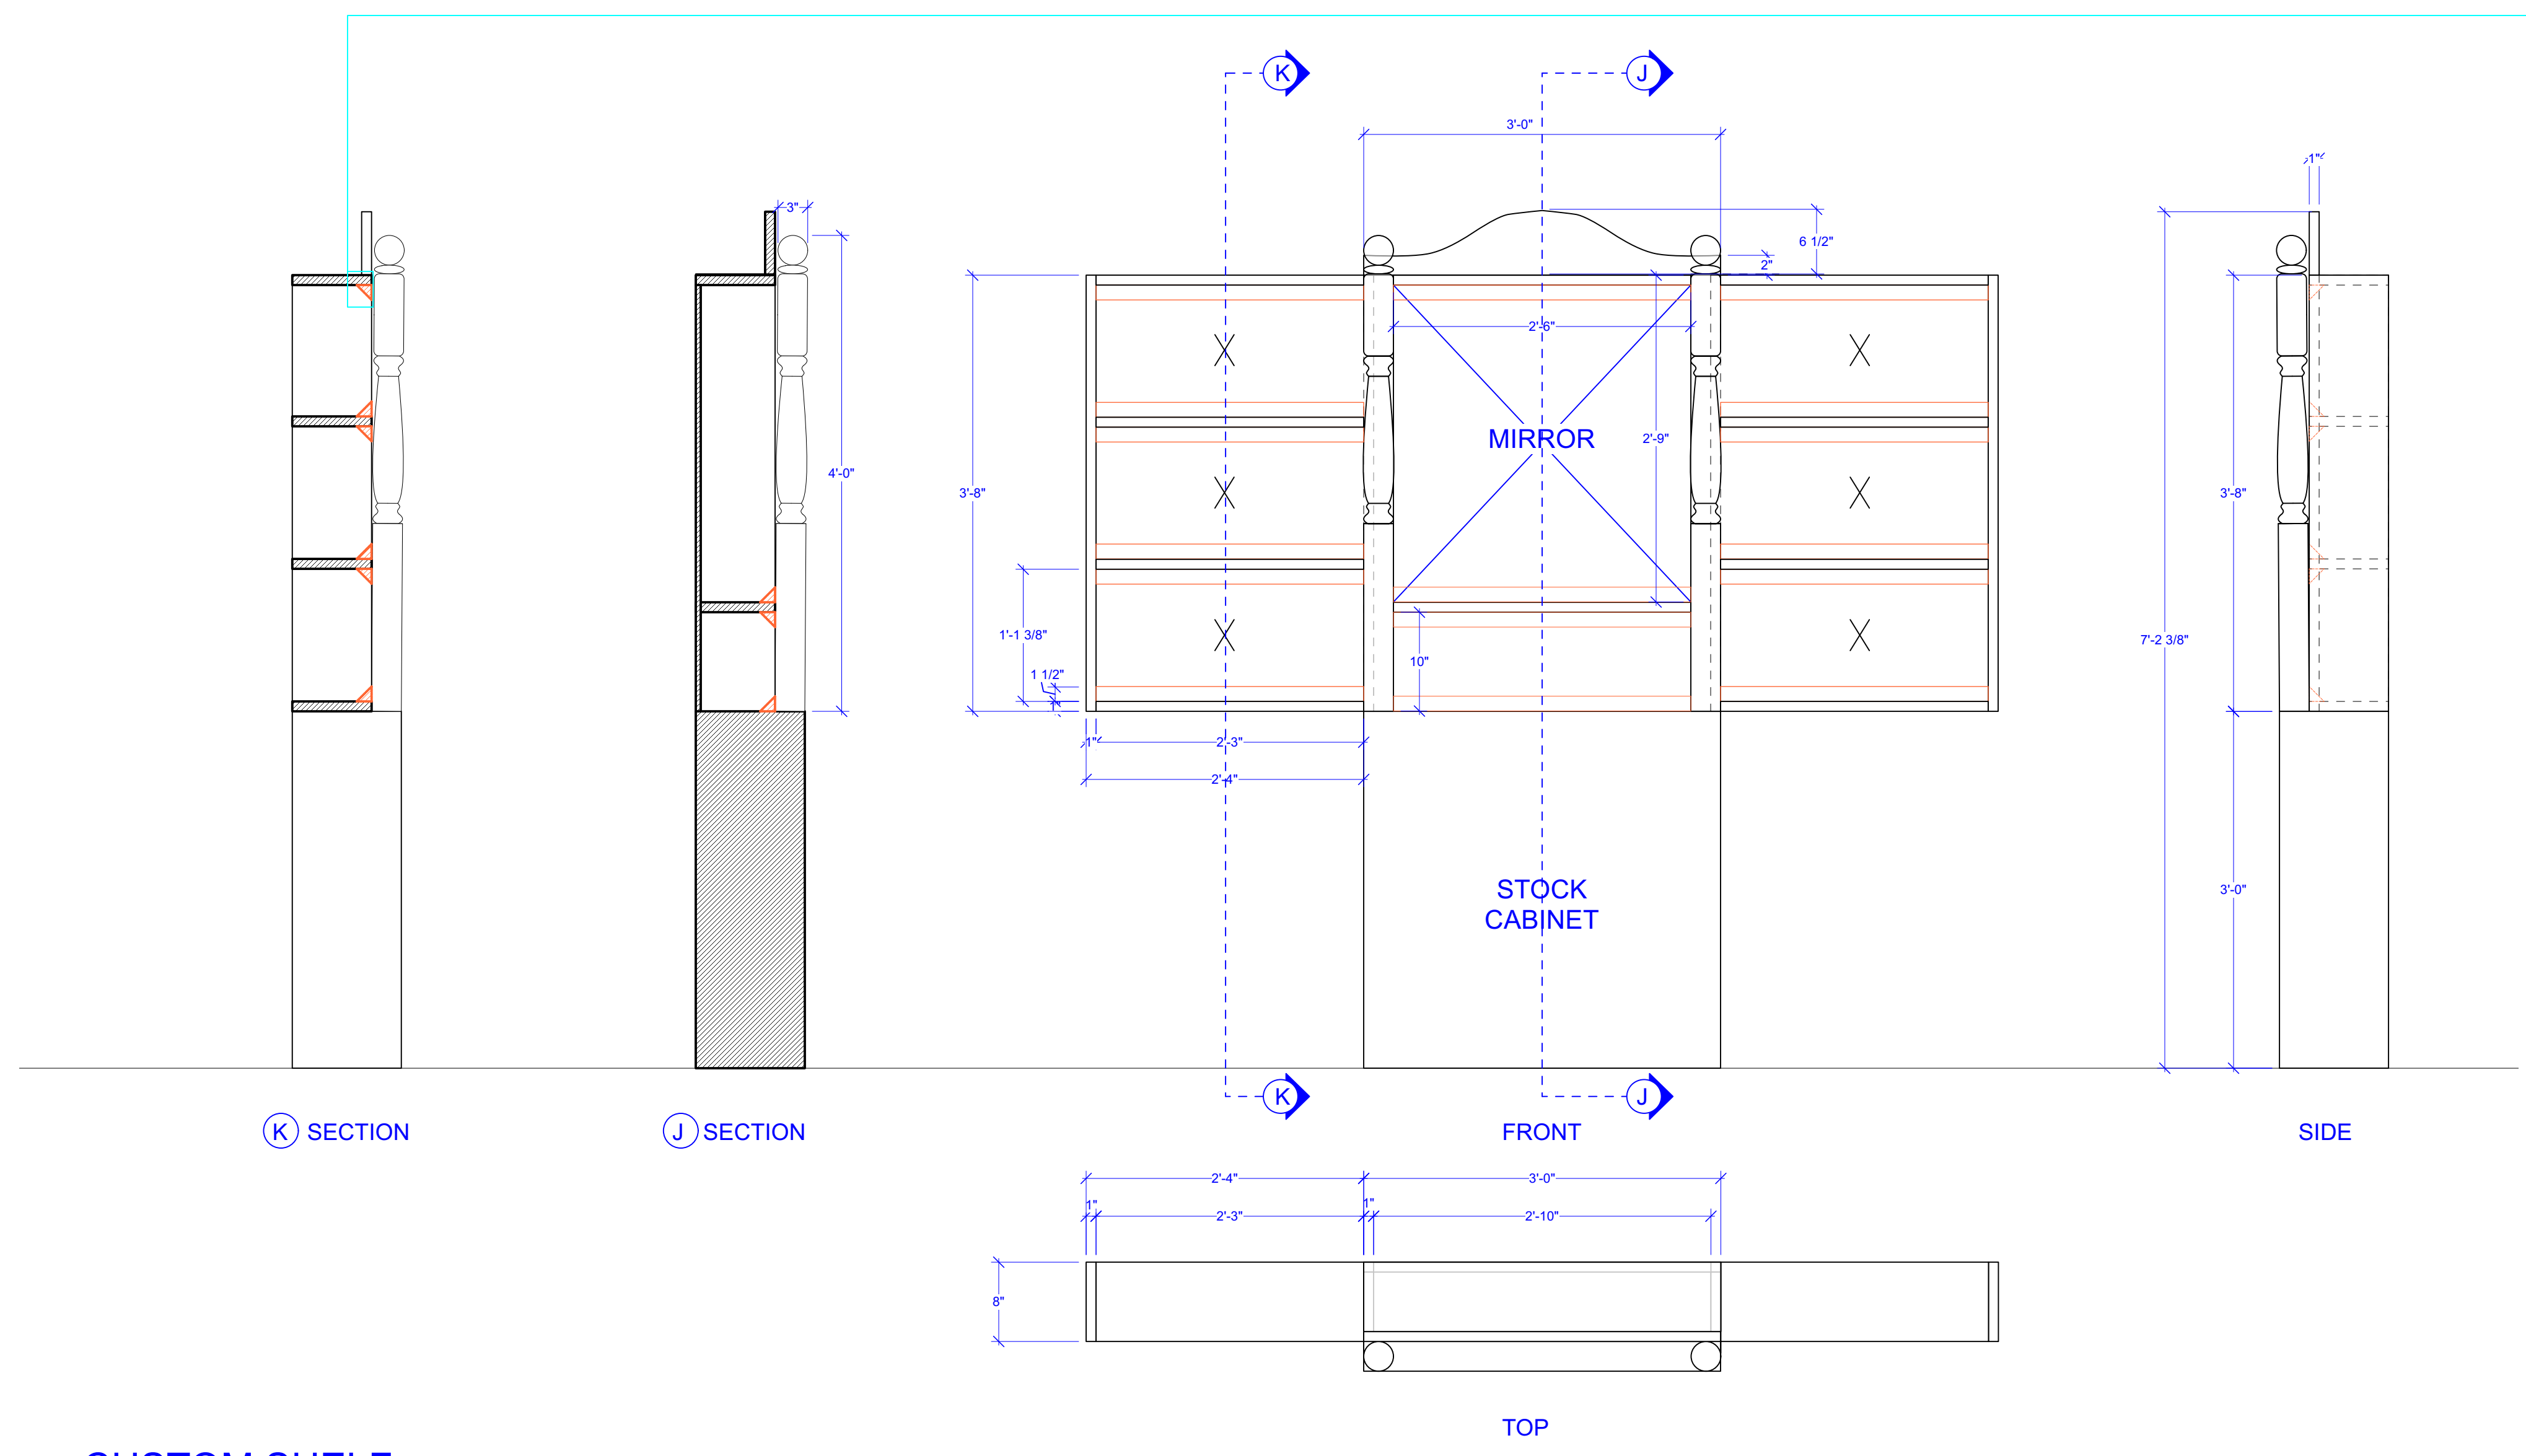

DETAIL: SECTION (H) BLOWUP - TRIANGLE+ LED UNIT
SCALE : FULL SCALE

NOTE:
- ORANGE TRIANGLES ARE 1.5 IN 45 DEGREE TRIANGLE ON EACH SHELF IS A "LIP" FOR LED TAPE TO BE PLACED
- LED TAPE STOCK FROM LIGHTING DEPARTMENT
- PLEASE SEE LIGHTING PLAN FOR MORE DETAILS- INCLUDED IN SCENIC FINALS GOOGLE DRIVE FOLDER



SIDE SHELVES PHOTO REFERENCE



DECORATIVE POLE EXAMPLE ANY DECORATIVE POLE SIMILAR CAN BE USED AS LONG AS HEIGHT IS OR SLIGHTLY HIGHER THAN 4 FOOT



CENTER SHELF PHOTO REFERENCE



BASE CABINET (IN STOCK AT PROP SHOP)
IMG_4221 36"w x 11"d x 36"h



PAINT : DARK WOOD - MATCH WITH BASE CABINET

CUSTOM SHELF
SCALE : 1" = 1'-0"

ELEVATION 2	SCALE: AS NOTED
SCENIC DESIGN: MARI YOSHIDA	NO. 6
DIRECTOR: JENNIFER CHANG	OF 6
TIME OF YOUR LIFE	DATE: 8/26/23
LITTLE THEATER UCLA	